

NOTES

مدرسة كراون الأمريكية الخاصة - مستند 714
1/7/2022



05	NUMBER OF STUDENTS REVISED	29/06/22	CS
04	MOE MEETING 04	09/05/22	CS
03	MOE MEETING 03	29/04/22	CS
02	MOE MEETING 02	27/04/22	CS
01	MOE MEETING 01	25/04/22	CS
No.	Revision	Date	Name

OWNER:
ABDULLA HUSSAIN MOHAMMED AL SHAALI ALALEELI

PROJECT DESCRIPTION:
G+1 CROWN AMERICAN PRIVATE SCHOOL

DRAWING TITLE:
SITE SETTING PLAN

PLOT NO. 0876 ARCH. ENG. AM


SECTOR MID SECTOR STRUC. ENG. JS

DISTRICT JURF 2 M.E.P. ENG. MJ

JOB NO. PP2022035 DRAWN BY: CS

SCALE 1:150 A2 CHECKED BY: RS

SHEET NO. A100 DATE: 29/06/2022

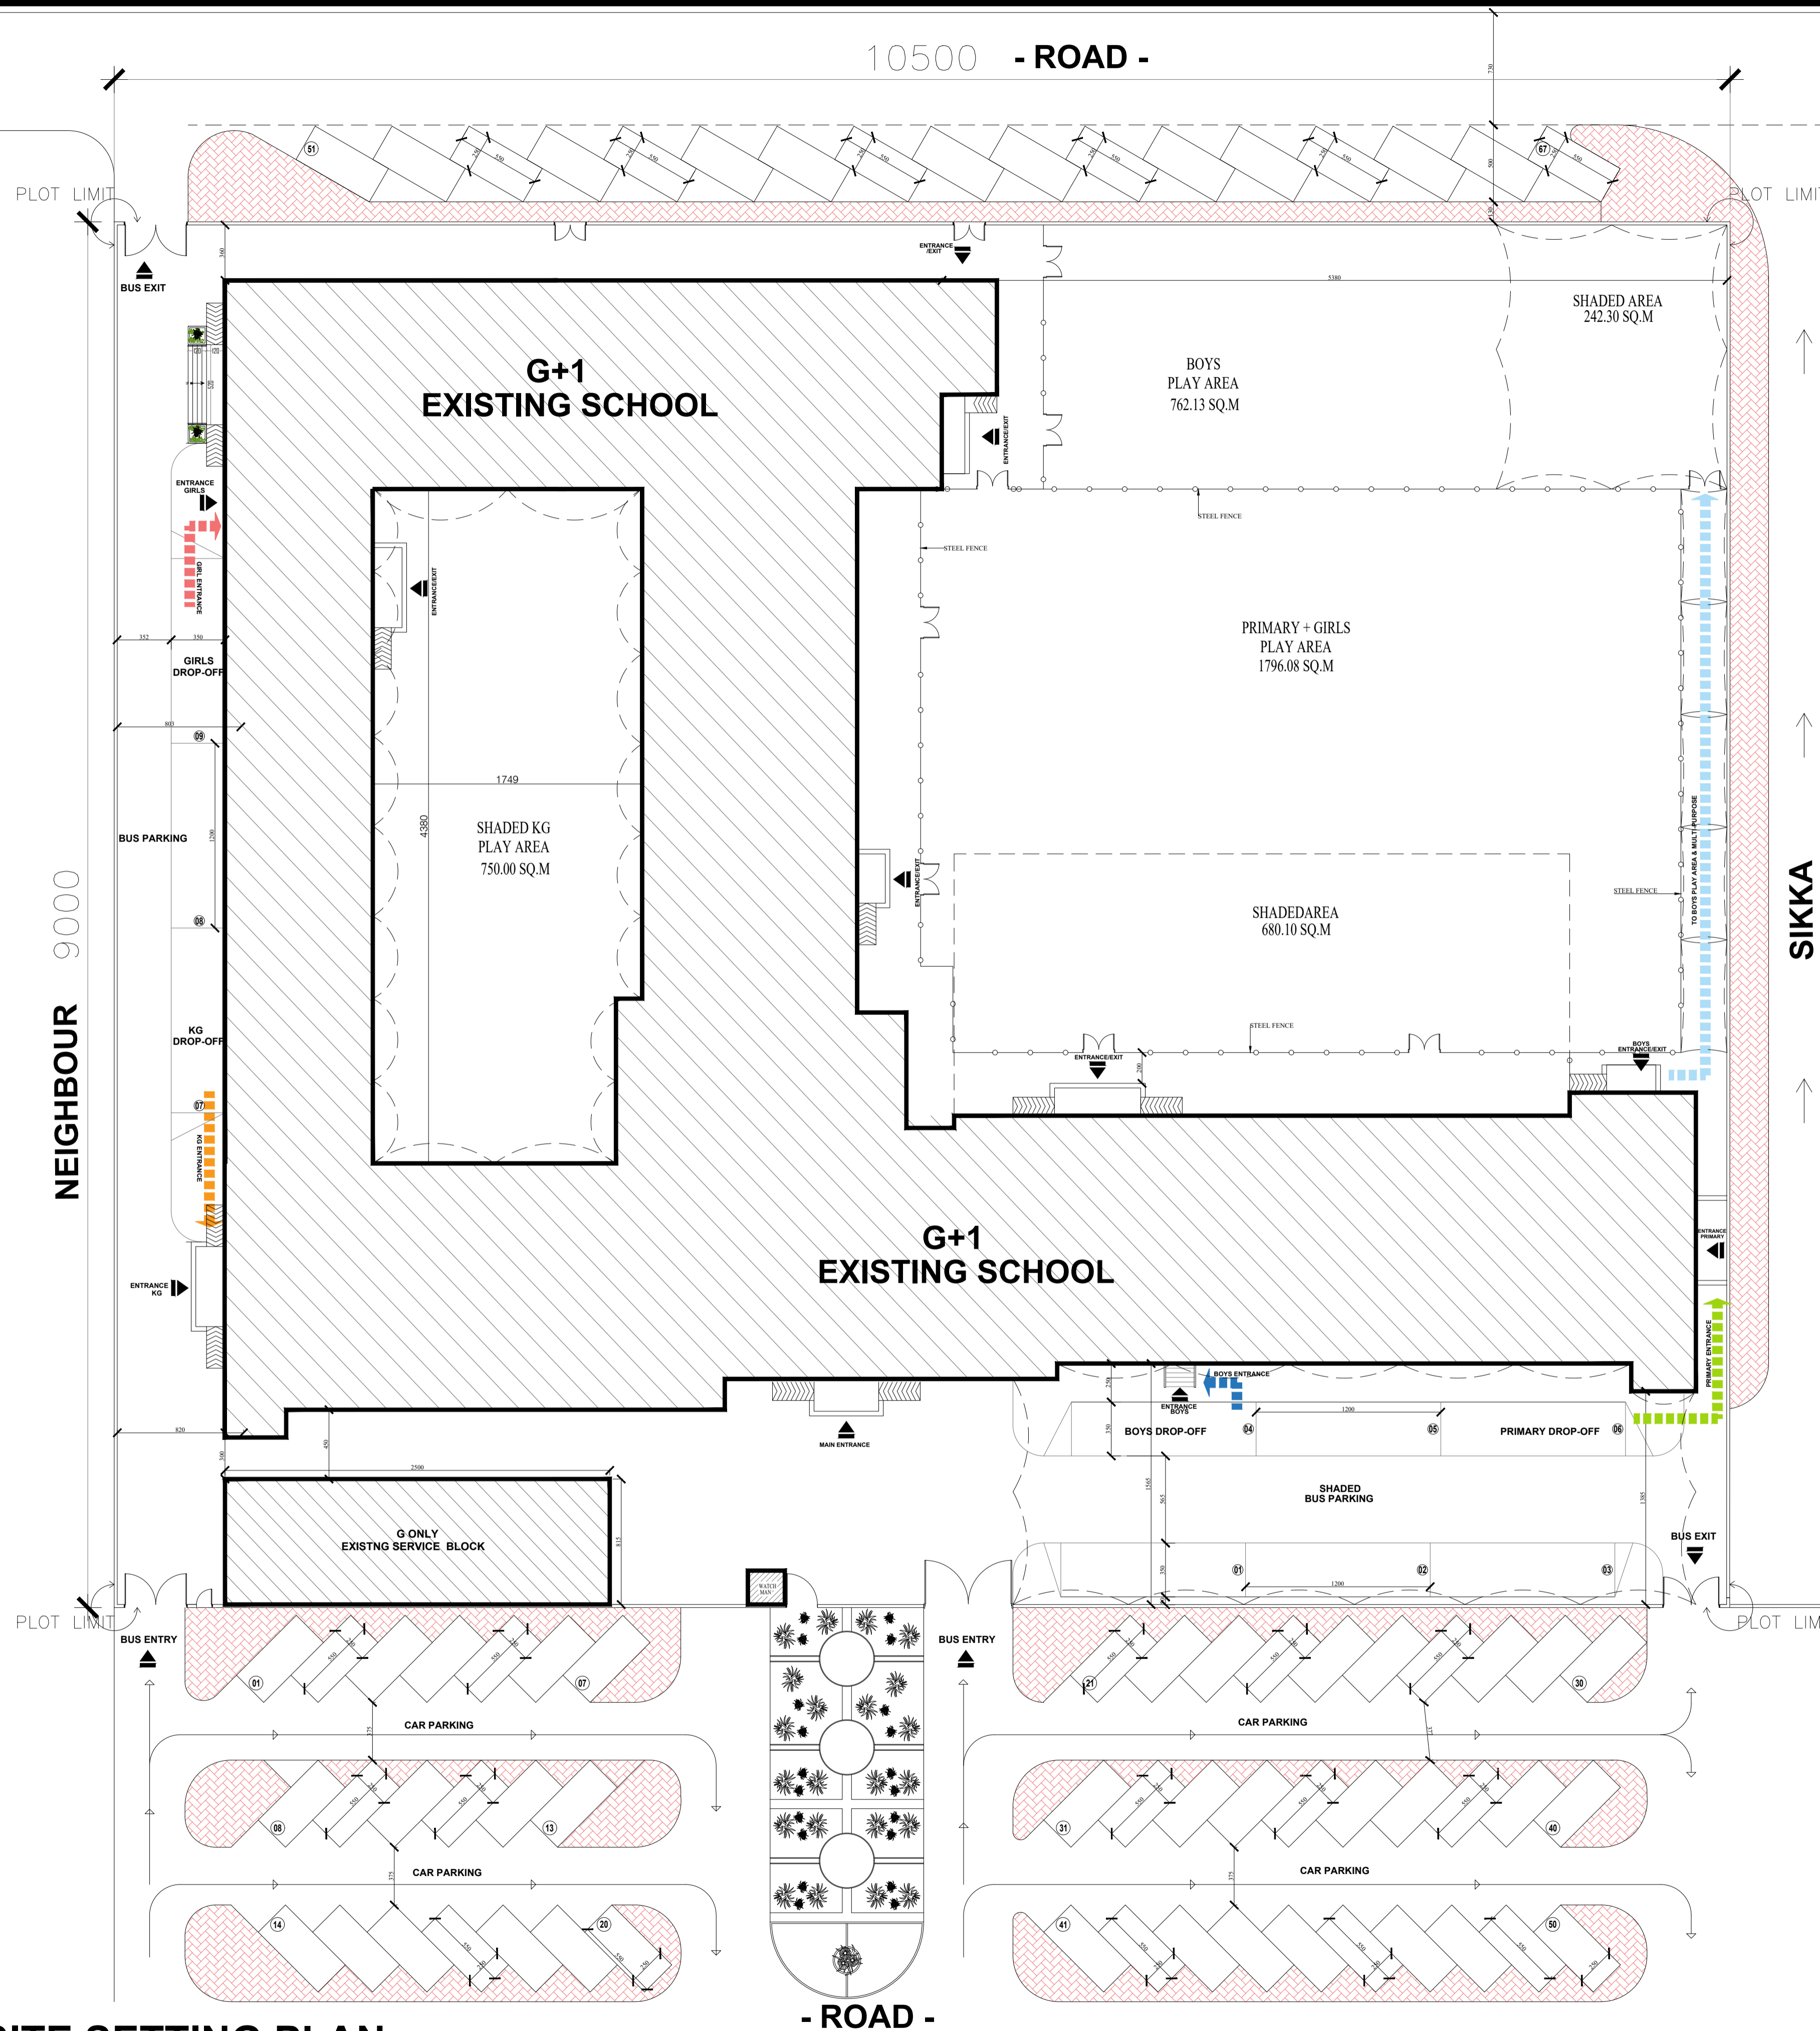

PLAY AREA	AREA (sq.m)	
	REQUIRED	PROVIDED
KG	800.00	750.00
PRIMARY & GIRLS	1600.00	1796.08
BOYS	720.00	762.13

MOE Curriculum				
GROUND FLOOR		FIRST FLOOR		
GRADE	NO. OF CLASSES	GRADE	NO. OF CLASSES	NO. OF CLASSES
			GIRLS	BOYS
KG 1	5	GR 5	1	2
KG 2	5	GR 6	1	1
GR 1	3	GR 7	1	1
GR 2	3	GR 8	1	1
GR 3	3	GR 9	1	1
GR 4	3	GR 10	1	1
		GR 11	1	1
		GR 12	1	1
TOTAL	22		8	9
TOTAL			39	

1 SITE SETTING PLAN
A-100 SCALE N.T.S

Evacuation Plan



CROWN AMERICAN PRIVATE SCHOOL
مدرسة كراون الامريكيا الخاصة

YOU ARE HERE



FIRE EXIT STAIRS




ASSEMBLY POINT



ارقام الطوارئ
الإسعاف: ٩٩٨
الدفاع المدني: ٩٩٧
الشرطة: ٩٩٩
الكهرباء: ٩٩١
المياه: ٩٩٢


EMERGENCY NUMBERS
AMBULANCE: 998
FIRE: 997
POLICE: 999
ELECTRICITY: 991
WATER: 992

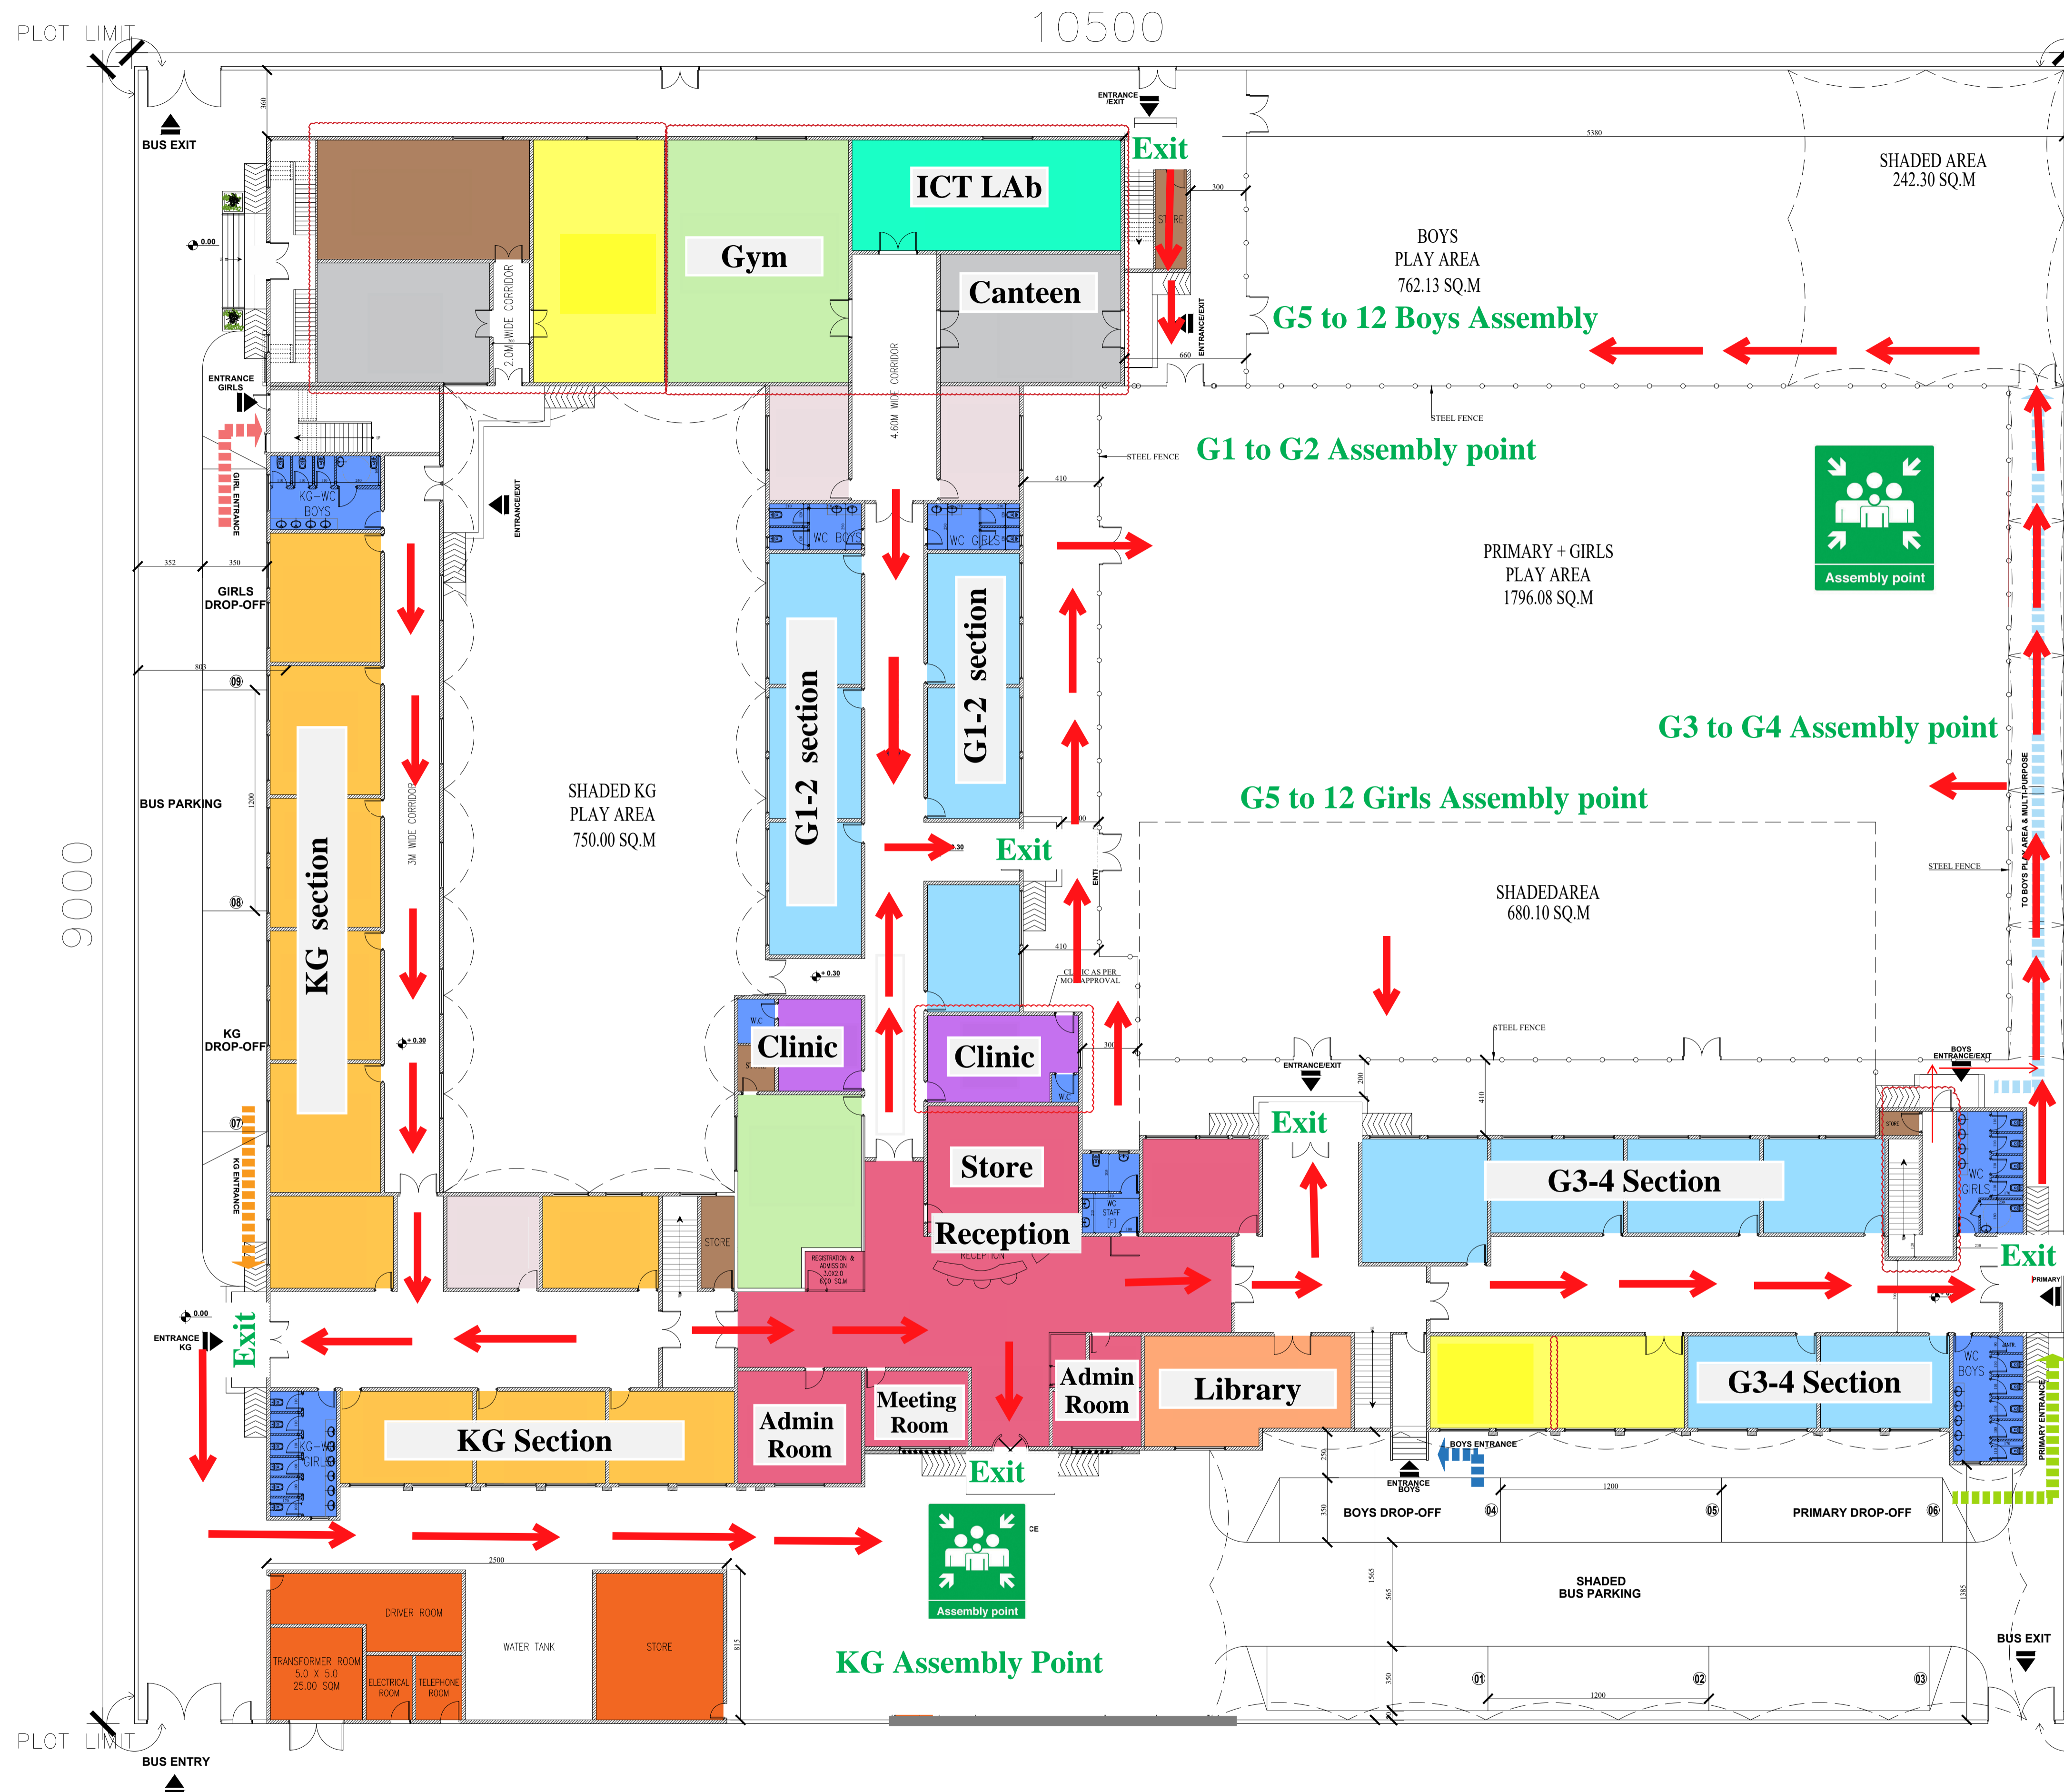

1 GROUND FLOOR PLAN
A-101 SCALE N.T.S

Updated on 22-Aug-2023

Evacuation Plan

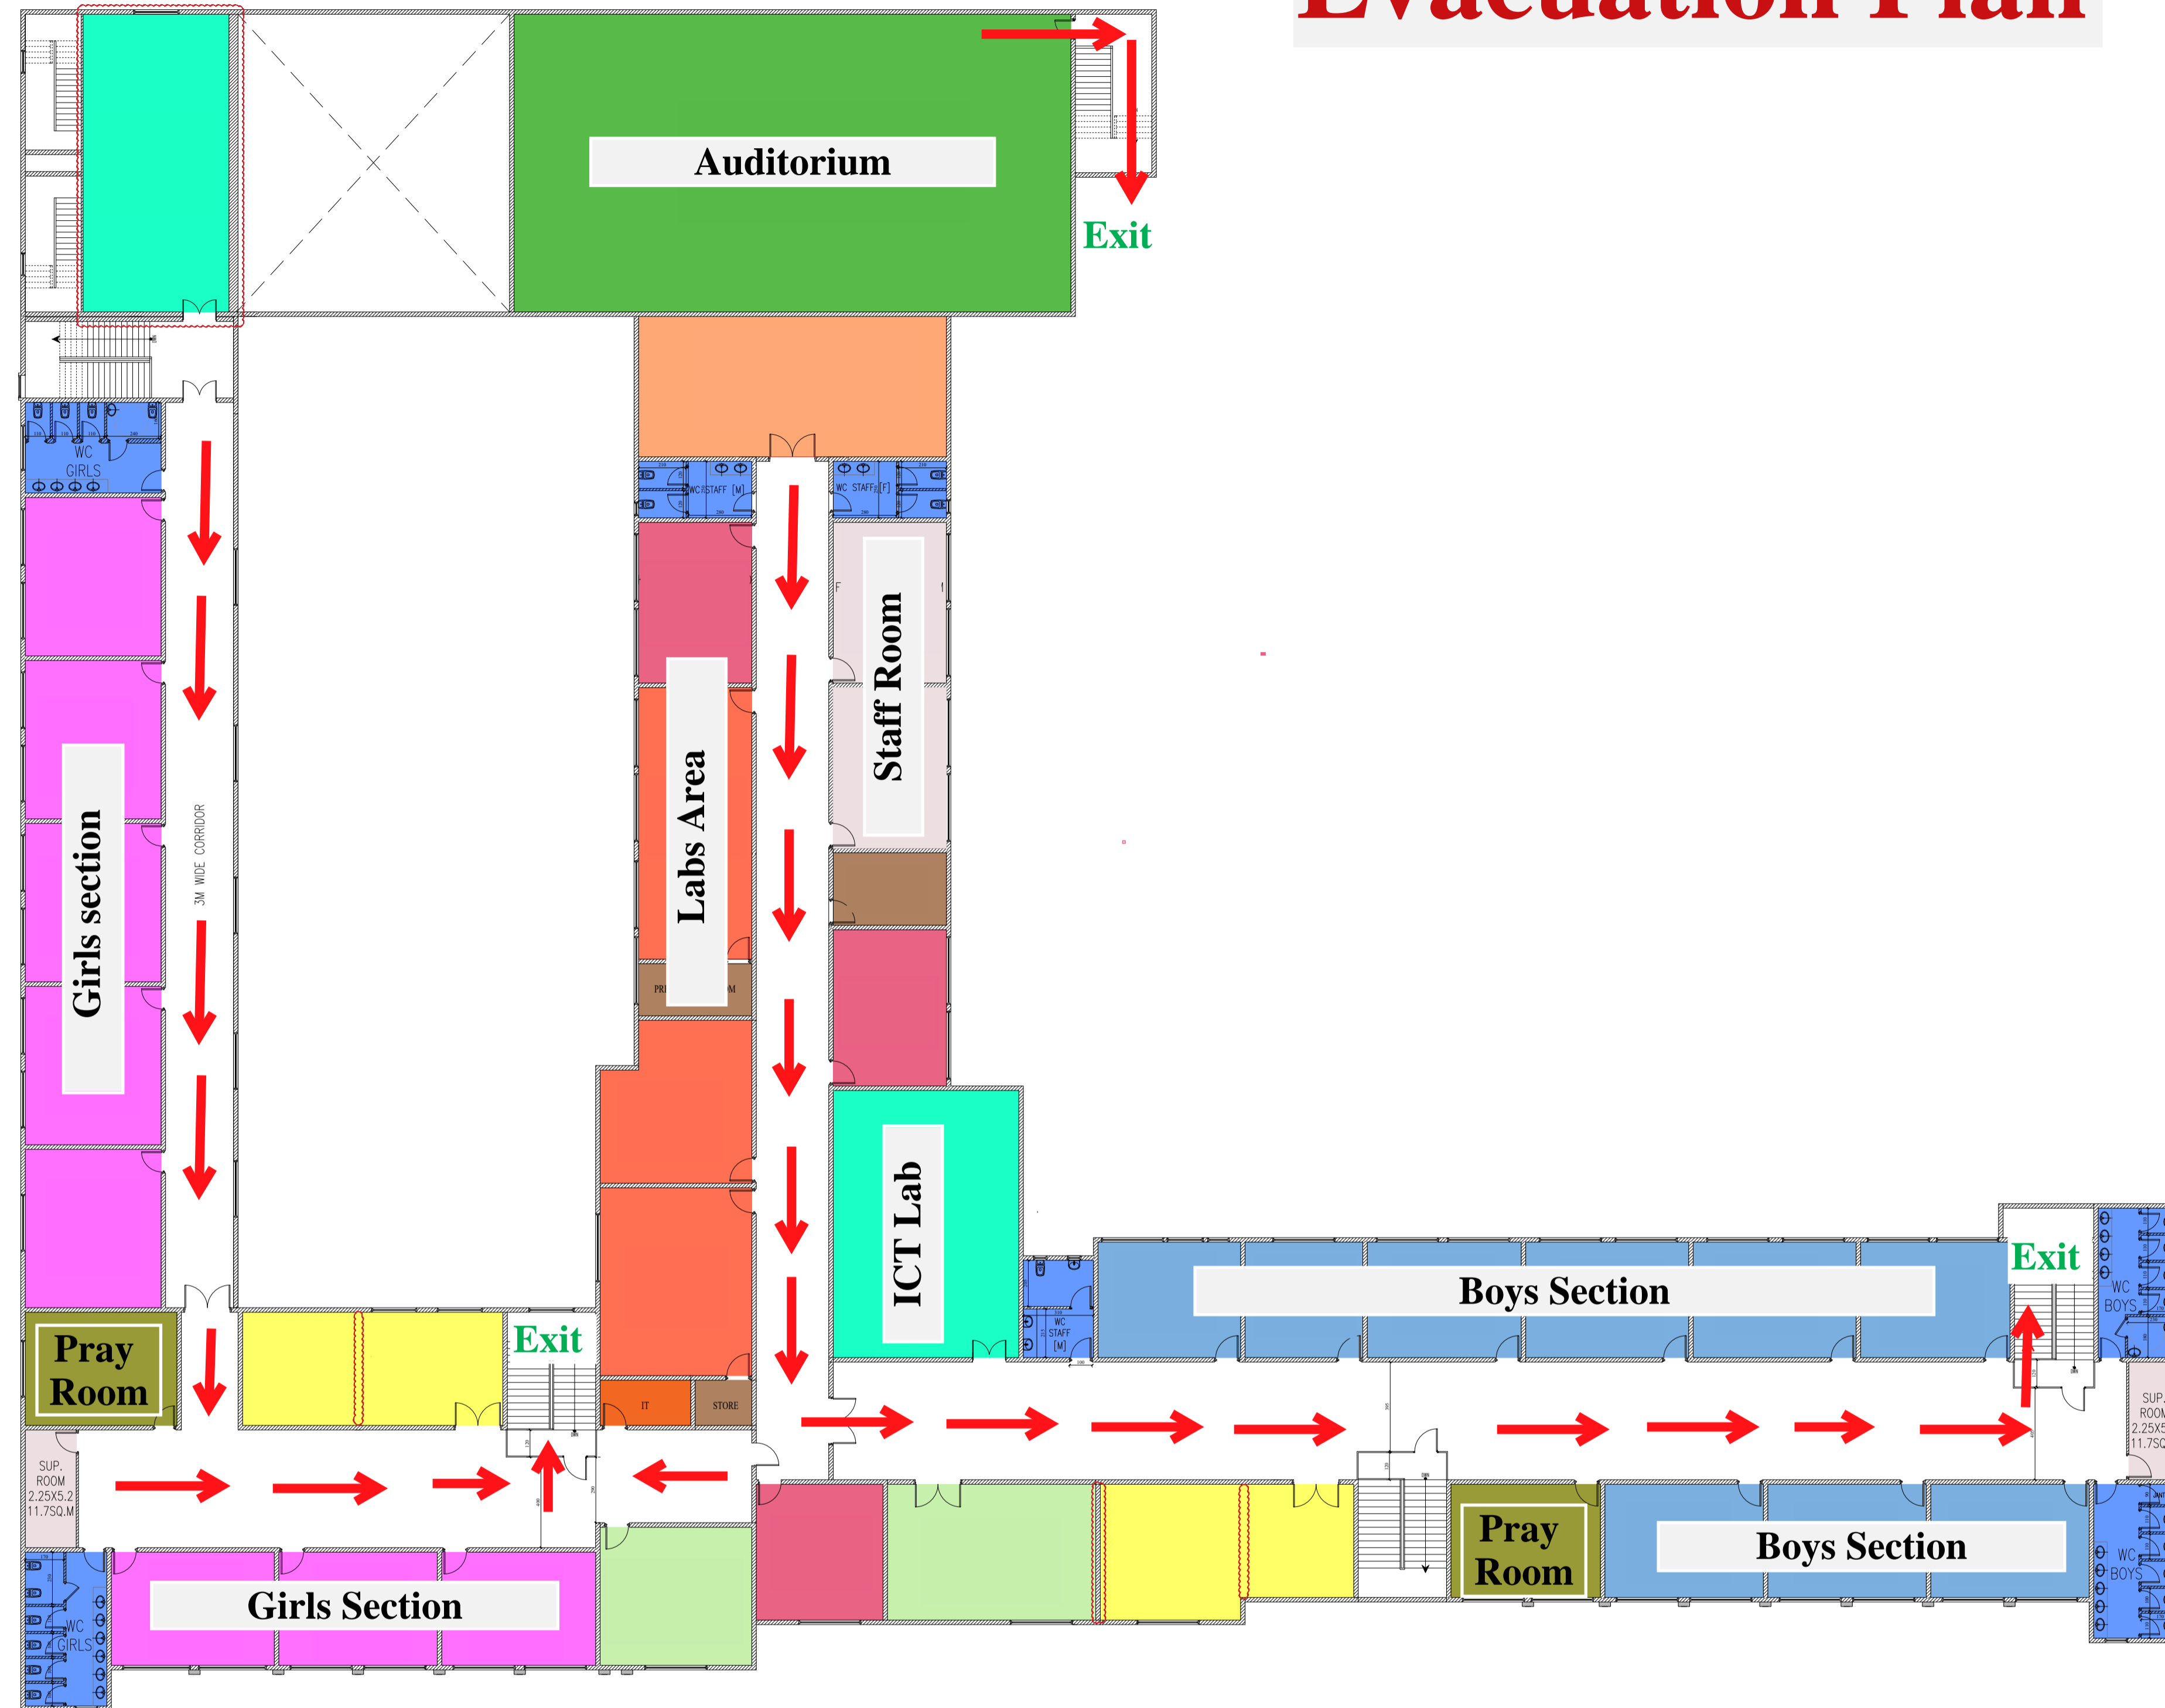

CROWN AMERICAN PRIVATE SCHOOL
مدرسة كراون الامريكيا الخاصة

YOU ARE HERE



FIRE EXIT STAIRS



ASSEMBLY POINT



أرقام الطوارئ
الإسعاف: ٩٩٨
الدفاع المدني: ٩٩٧
الشرطة: ٩٩٩
الكهرباء: ٩٩١
المياه: ٩٩٢

EMERGENCY NUMBERS

AMBULANCE: 998

FIRE: 997

POLICE: 999

ELECTRICITY: 991

WATER: 992

1 FIRST FLOOR PLAN

A-102 SCALE N.T.S